

A RESOLUTION SUPPORTING THE IMPLEMENTATION
OF A STREET LIGHTING REPLACEMENT PROGRAM

WHEREAS, the City Council of the City of Urbana, Illinois, has found that it is in the best interests of the citizens of Urbana to have a dependable street lighting system on various roadways within the City of Urbana.

AND WHEREAS, the City Council, on October 16, 1995, adopted Resolution 9596-R10 accepting the technical, design and funding recommendations contained in the September, 1995 "Series Street Lighting Report".

NOW, THEREFORE, BE IT RESOLVED BY THE CITY COUNCIL OF THE CITY OF URBANA, ILLINOIS, as follows:


1. The City Council hereby acknowledges receipt of a memorandum called "Series Streetlighting Recommendations From City Staff And A Citizen Focus Group", dated December 4, 1997, and hereby expresses its support of Staff Recommendations # 1, 2, and 3 as outlined in that memorandum. Specifically, the City Council endorses the use of a traditional round white globe for use on low height ornamental poles. Additionally, the City Council supports the use of varying styles of "house-side shields" as explained in the memorandum. And, furthermore, the City Council concurs that the type of light source to be used in all low height ornamental poles shall be a 3200K metal halide luminaire.
2. The City Council also endorses Staff Recommendation 4A, whereby certain streets, specifically those identified in the map, hereby attached, "Proposed Near-Campus And High Density Residential Increased Lighting Plan" shall use 100 watt lamps whereas all other local streets with low height ornamental poles in the series system replacement project shall use 70 watt lamps and whereby certain streets that are currently unlit will also be lit with 100 watt lamps. The estimated additional cost of \$87,500 to implement this "near-campus" plan shall be incorporated into the City of Urbana Capital Improvement Plan. City staff, as part of the 1998 Capital Improvement Plan Update presented for Council approval, shall include a specific recommendation on how to restructure the Capital Improvement Plan to incorporate this additional expense.
3. This resolution is hereby passed by the affirmative vote, the "ayes" and "nays" being called, of a majority of the members of the Council of the City of Urbana, Illinois, at a regular meeting of said Council on the 15th day of December, 1997.

PASSED by the City Council this 15th day of December, 1997.

AYES:

NAYS:

ABSTAINS:

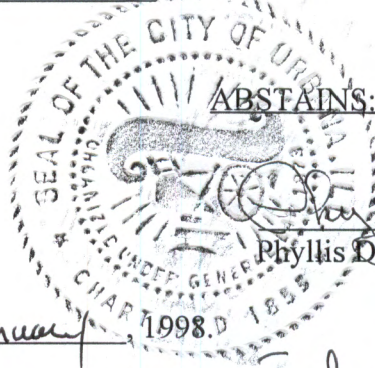


Phyllis D. Clark
Phyllis D. Clark, City Clerk

APPROVED by the Mayor this 5th day of January, 1998.

Tod Satterthwaite
Tod Satterthwaite, Mayor



THIS RESOLUTION CONSISTS OF 1 PAGES.

Initials SR

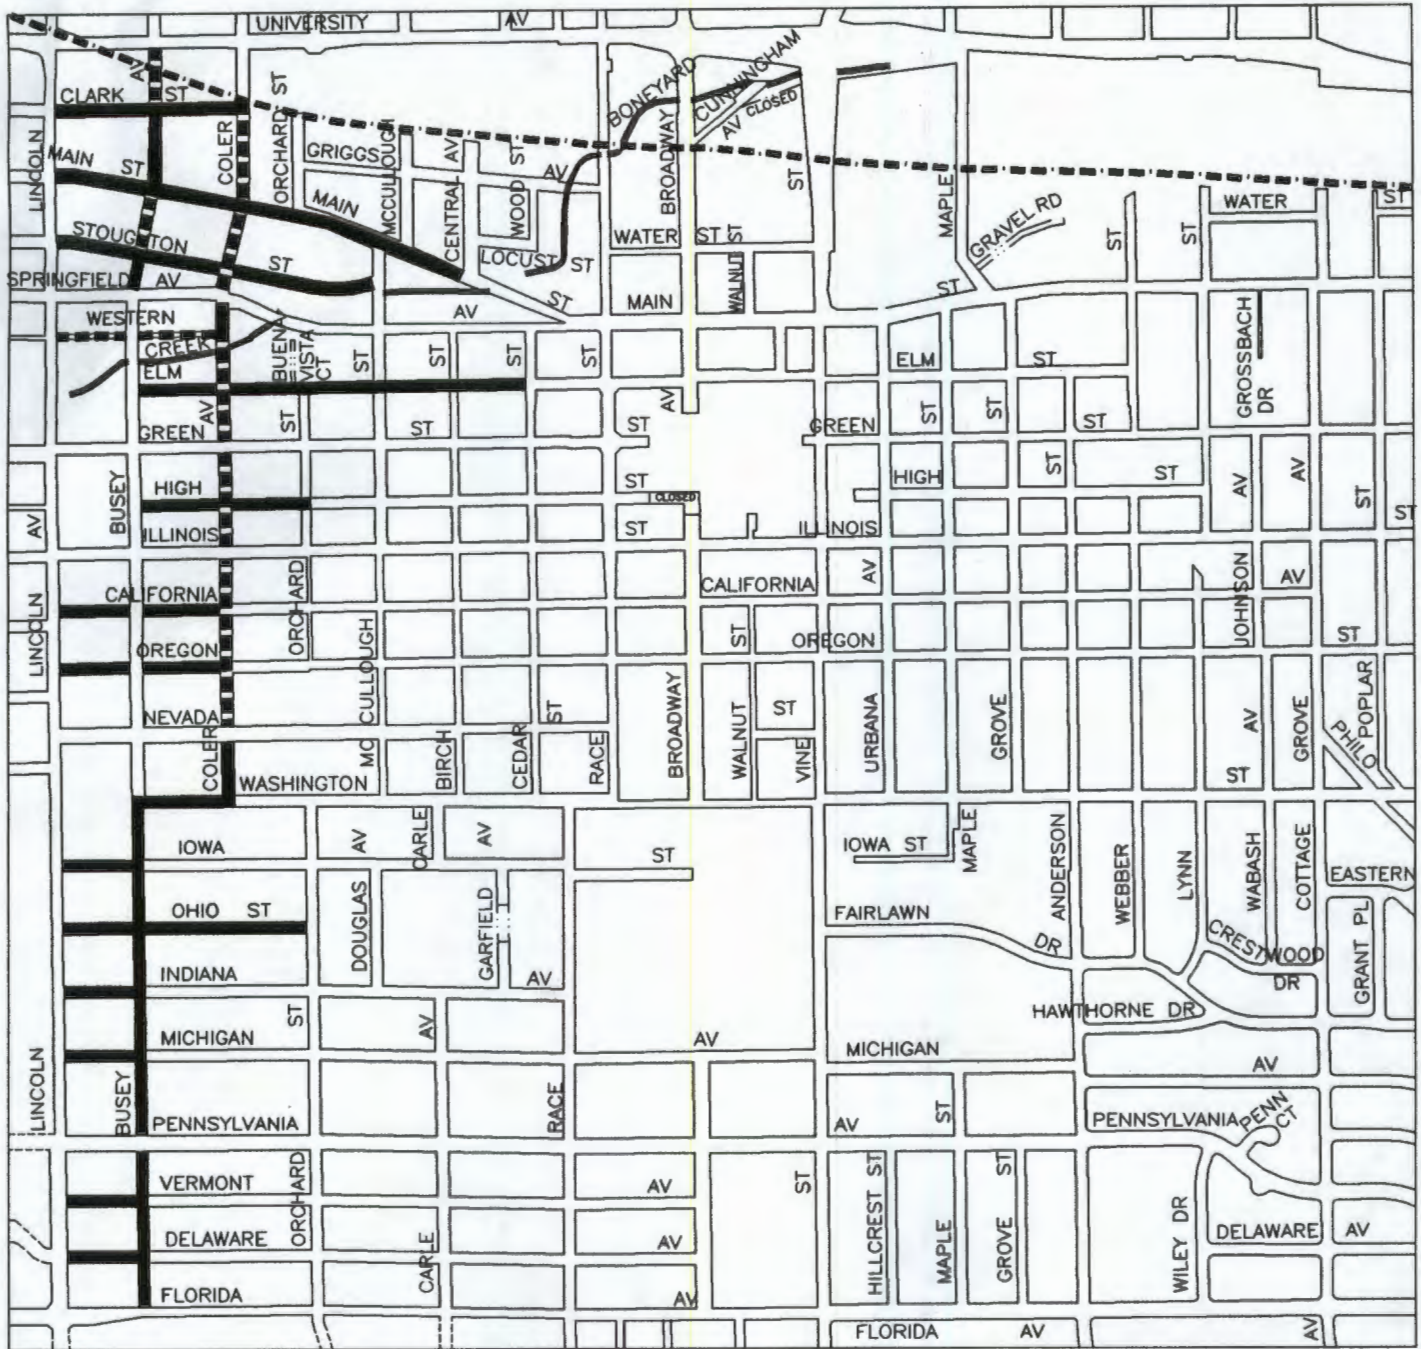

LEGEND

 

-  - CURRENTLY LIT SERIES STREET TO BE RELIT WITH 100 WATT LAMPS AS PART OF NEAR CAMPUS PLAN
-  - CURRENTLY UNLIT STREET TO RECEIVE 100 WATT LAMPS AS PART OF NEAR CAMPUS PLAN



PROPOSED NEAR-CAMPUS AND HIGH DENSITY RESIDENTIAL INCREASED LIGHTING PLAN

CITY OF URBANA
 PUBLIC WORKS DEPT.
 ENGINEERING DIVISION
 Drawn By: JLS 12/5/1997